


Rev.	Date	Revision
1	16.12.01	ISSUES ADDED
2	16.12.01	ISSUES 1 & 2 ADDED
3	16.12.01	ISSUES 1 & 2 ADDED
4	16.12.01	ISSUES 1 & 2 ADDED
5	16.12.01	ISSUES 1 & 2 ADDED
6	16.12.01	ISSUES 1 & 2 ADDED
7	16.12.01	ISSUES 1 & 2 ADDED
8	16.12.01	ISSUES 1 & 2 ADDED
9	16.12.01	ISSUES 1 & 2 ADDED
10	16.12.01	ISSUES 1 & 2 ADDED
11	16.12.01	ISSUES 1 & 2 ADDED
12	16.12.01	ISSUES 1 & 2 ADDED
13	16.12.01	ISSUES 1 & 2 ADDED
14	16.12.01	ISSUES 1 & 2 ADDED
15	16.12.01	ISSUES 1 & 2 ADDED
16	16.12.01	ISSUES 1 & 2 ADDED
17	16.12.01	ISSUES 1 & 2 ADDED
18	16.12.01	ISSUES 1 & 2 ADDED
19	16.12.01	ISSUES 1 & 2 ADDED
20	16.12.01	ISSUES 1 & 2 ADDED
21	16.12.01	ISSUES 1 & 2 ADDED
22	16.12.01	ISSUES 1 & 2 ADDED
23	16.12.01	ISSUES 1 & 2 ADDED
24	16.12.01	ISSUES 1 & 2 ADDED
25	16.12.01	ISSUES 1 & 2 ADDED
26	16.12.01	ISSUES 1 & 2 ADDED
27	16.12.01	ISSUES 1 & 2 ADDED
28	16.12.01	ISSUES 1 & 2 ADDED
29	16.12.01	ISSUES 1 & 2 ADDED
30	16.12.01	ISSUES 1 & 2 ADDED
31	16.12.01	ISSUES 1 & 2 ADDED
32	16.12.01	ISSUES 1 & 2 ADDED
33	16.12.01	ISSUES 1 & 2 ADDED
34	16.12.01	ISSUES 1 & 2 ADDED
35	16.12.01	ISSUES 1 & 2 ADDED
36	16.12.01	ISSUES 1 & 2 ADDED
37	16.12.01	ISSUES 1 & 2 ADDED
38	16.12.01	ISSUES 1 & 2 ADDED
39	16.12.01	ISSUES 1 & 2 ADDED
40	16.12.01	ISSUES 1 & 2 ADDED
41	16.12.01	ISSUES 1 & 2 ADDED
42	16.12.01	ISSUES 1 & 2 ADDED
43	16.12.01	ISSUES 1 & 2 ADDED
44	16.12.01	ISSUES 1 & 2 ADDED
45	16.12.01	ISSUES 1 & 2 ADDED
46	16.12.01	ISSUES 1 & 2 ADDED
47	16.12.01	ISSUES 1 & 2 ADDED
48	16.12.01	ISSUES 1 & 2 ADDED
49	16.12.01	ISSUES 1 & 2 ADDED
50	16.12.01	ISSUES 1 & 2 ADDED

BRUNEL
 ENGINEERING CONSULTANTS LTD
 1 Gloucester Row
 Clifton
 Bristol BS8 4AW
 TN 0117 973 0836 FX 0117 973 1897

Contract
 REEDSPACE LIMITED
 PROPOSED OFFICE DEVELOPMENT
 EASTERN ROAD, BRACKNELL

Drawing Title
 UNIT L - FIRST FLOOR
 LIGHTING SERVICES
 25.1.02

Drawing Status
 TENDER/CONTRACT
 Date: DEC 2000 Scale: 1:50
 Drawing Number
 9193/LFF/EZ
 Rev. C

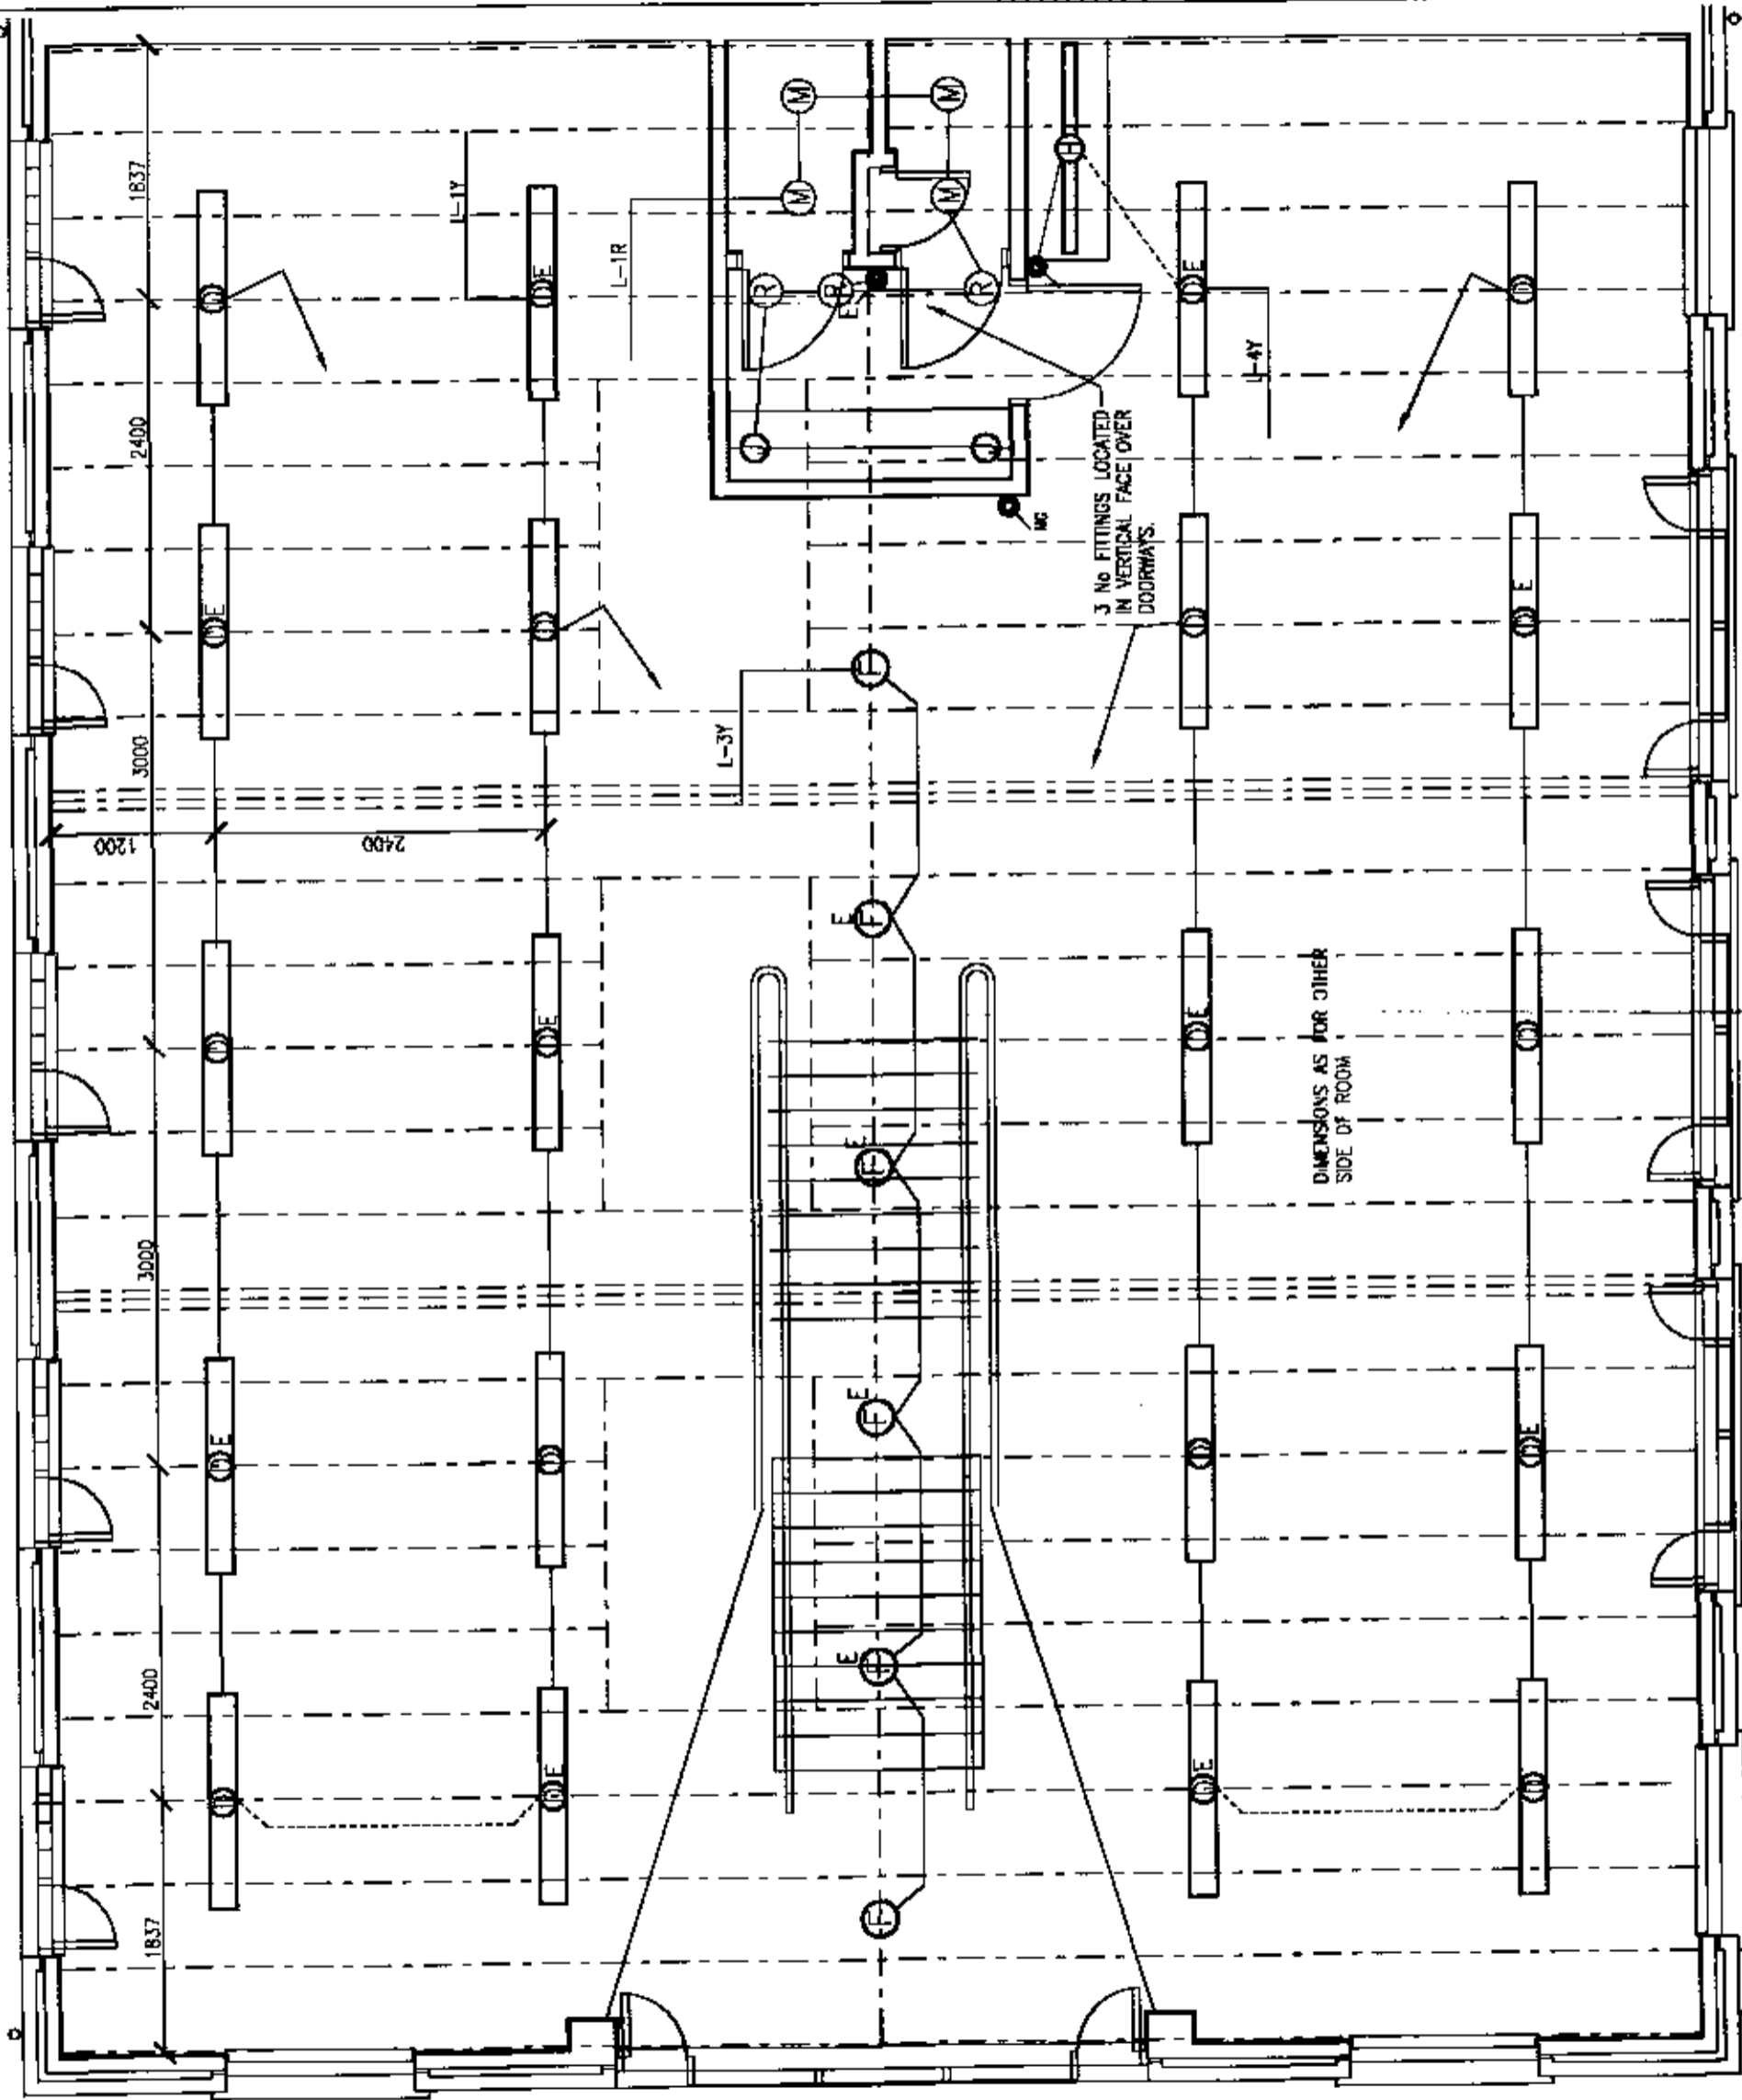

UNIT L - FIRST FLOOR PLAN