



CENTRE LINE OF FITTINGS TO BE ON CENTRE LINE OF WINDOWS

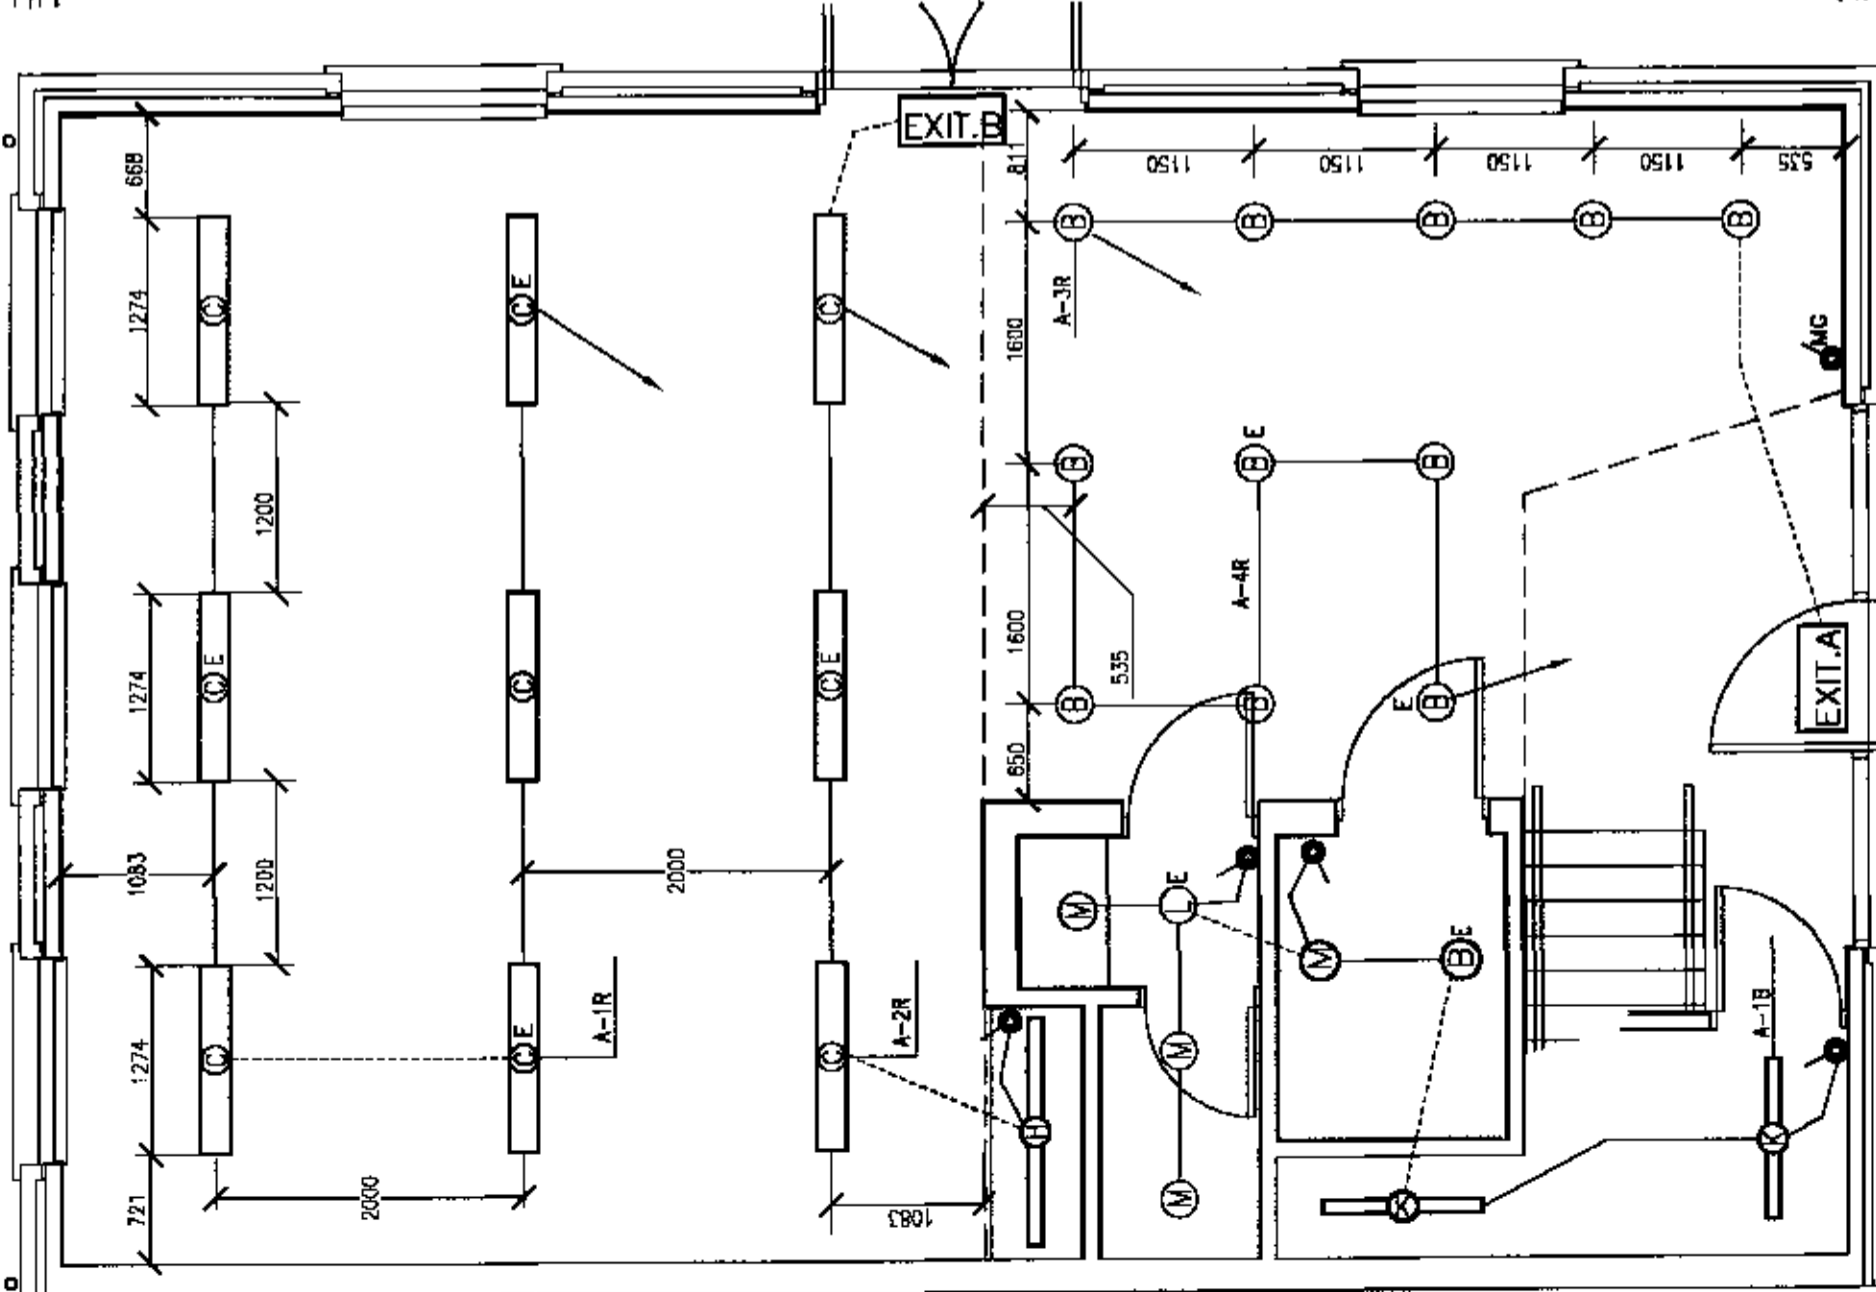

UNIT A - GROUND FLOOR PLAN

CENTRE LINE OF FITTINGS TO BE ON CENTRE LINE OF WINDOWS

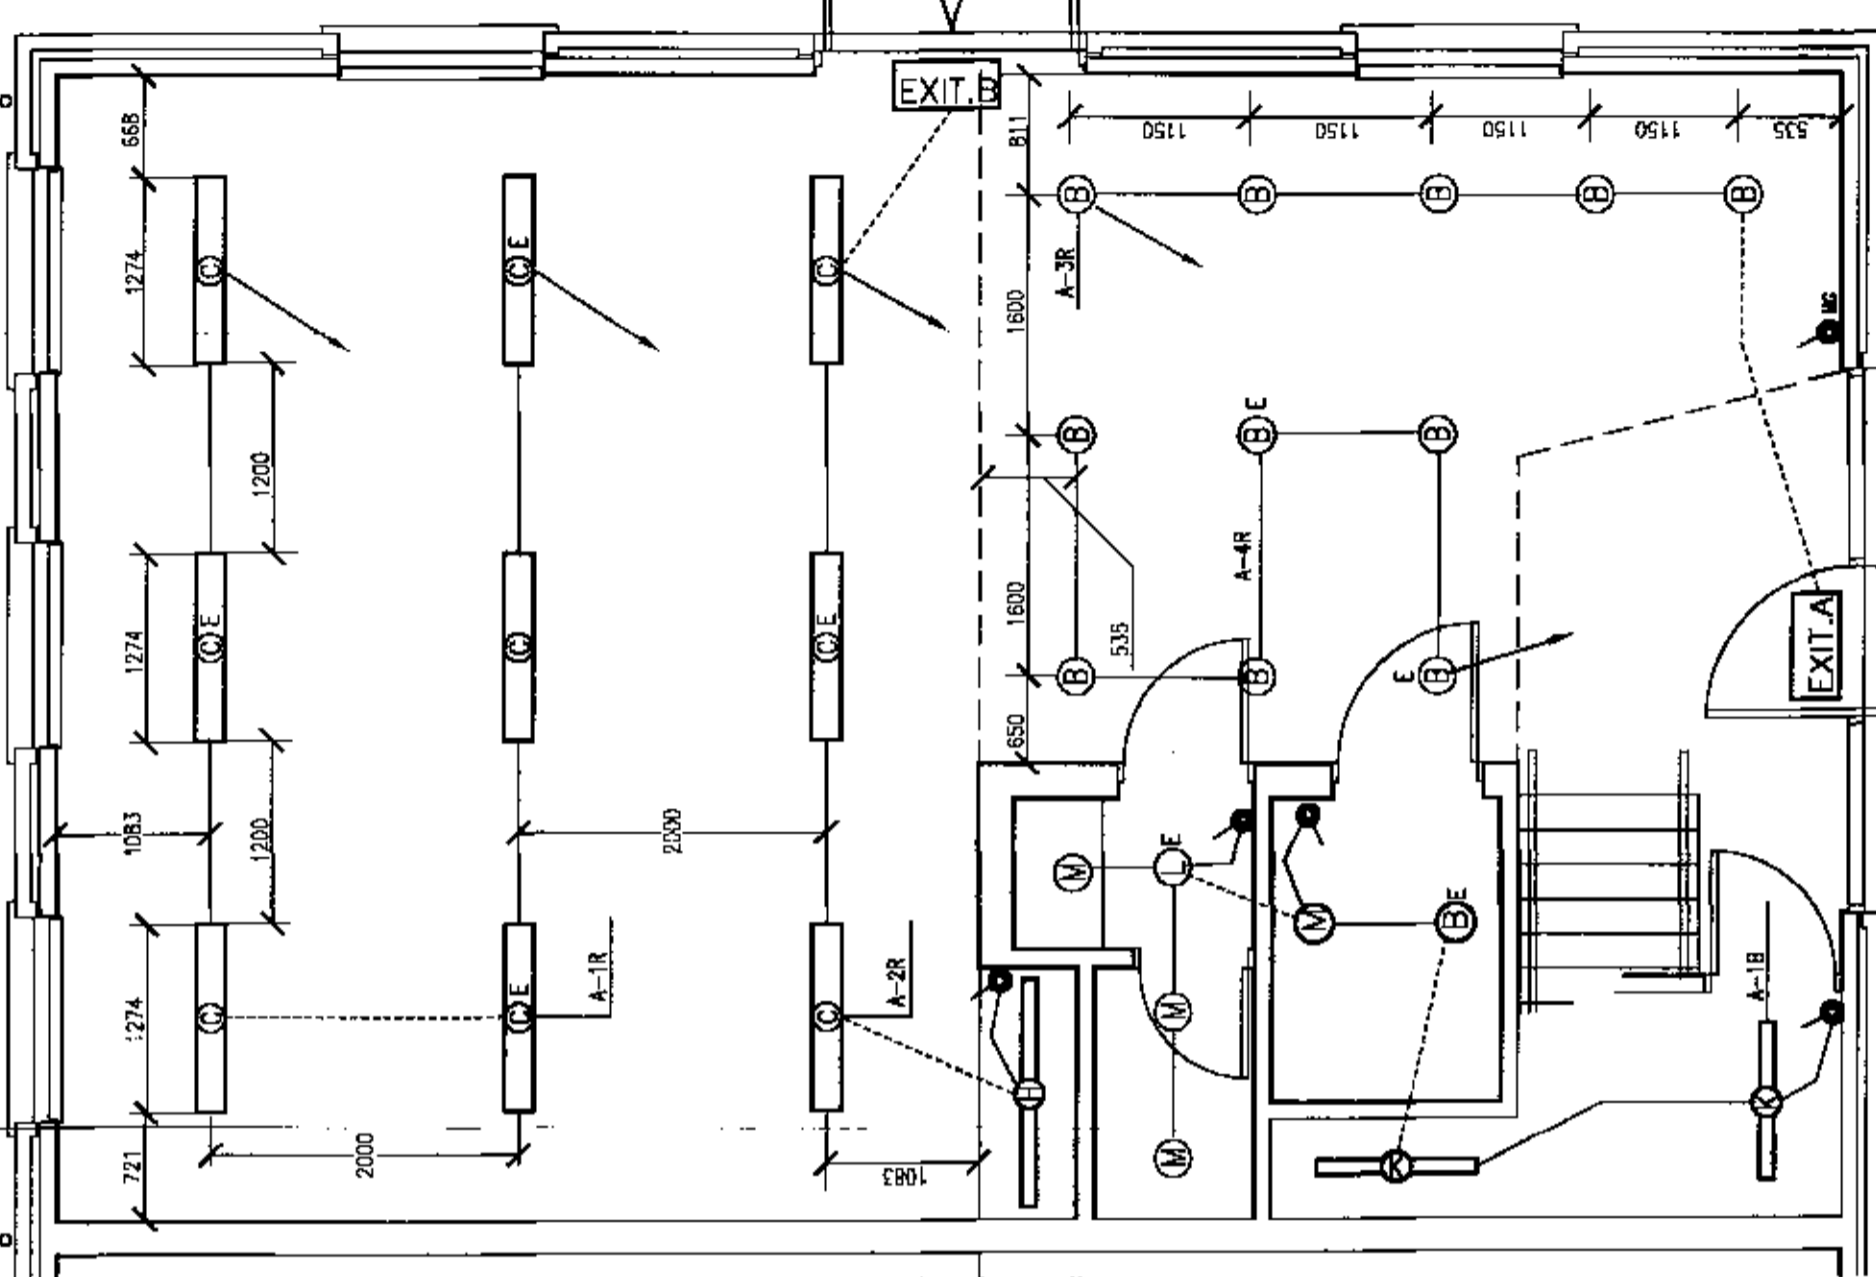

UNIT E - GROUND FLOOR PLAN

Rev.	Date	Revisions
1	15.06.02	TYPE B FITTINGS REQUIRED FROM 15.06.02
2	24.06.02	REVISIONS ADDED TO TYPE N FITTINGS REFERRED TO IN 15.06.02
3	27.07.02	ADDED TYPE N FITTINGS TO THE 15.06.02 AND 24.06.02 REVISIONS
4	16.03.03	ADDED TYPE N FITTINGS TO THE 15.06.02, 24.06.02 AND 27.07.02 REVISIONS
5	16.03.03	ADDED TYPE N FITTINGS TO THE 15.06.02, 24.06.02, 27.07.02 AND 16.03.03 REVISIONS

**BRUNEL**  
 ENGINEERING CONSULTANTS LTD  
 1 Gloucester Row  
 Clifton  
 Bristol BS8 4AW  
 TN 0117 973 0836 FX 0117 973 0897

Contract  
**REEDSPACE LIMITED**  
 PROPOSED OFFICE DEVELOPMENT  
 EASTERN ROAD, BRACKNELL

Drawing Title  
**UNITS A & E - GROUND FLOOR LIGHTING SERVICES**

1.2.02

Drawing Status  
**CONTRACT**  
 Date: DEC 2000 Scale: 1:50  
 Drawing Number  
**9193/A-E/GF/E2**  
 Rev. **D**