

NOTES

Rev.	Date	Revisions


BRUNEL
 ENGINEERING CONSULTANTS LTD
 1 Gloucester Row
 Clifton
 Bristol BS8 4AW
 TN. 0117 973 0835 FX. 0117 973 1895

Contract
 REEDSPACE LIMITED
 PROPOSED OFFICE DEVELOPMENT
 EASTERN ROAD, BRACKNELL

Drawing Title
 SITE PLAN
 DISTRIBUTION OF SERVICES

Drawing Status
 CONTRACT

Date : MAY 2002 Scale 1 : 150
 Drawing Number
 9193/S2 - SHEET 1 OF 4 Rev. -

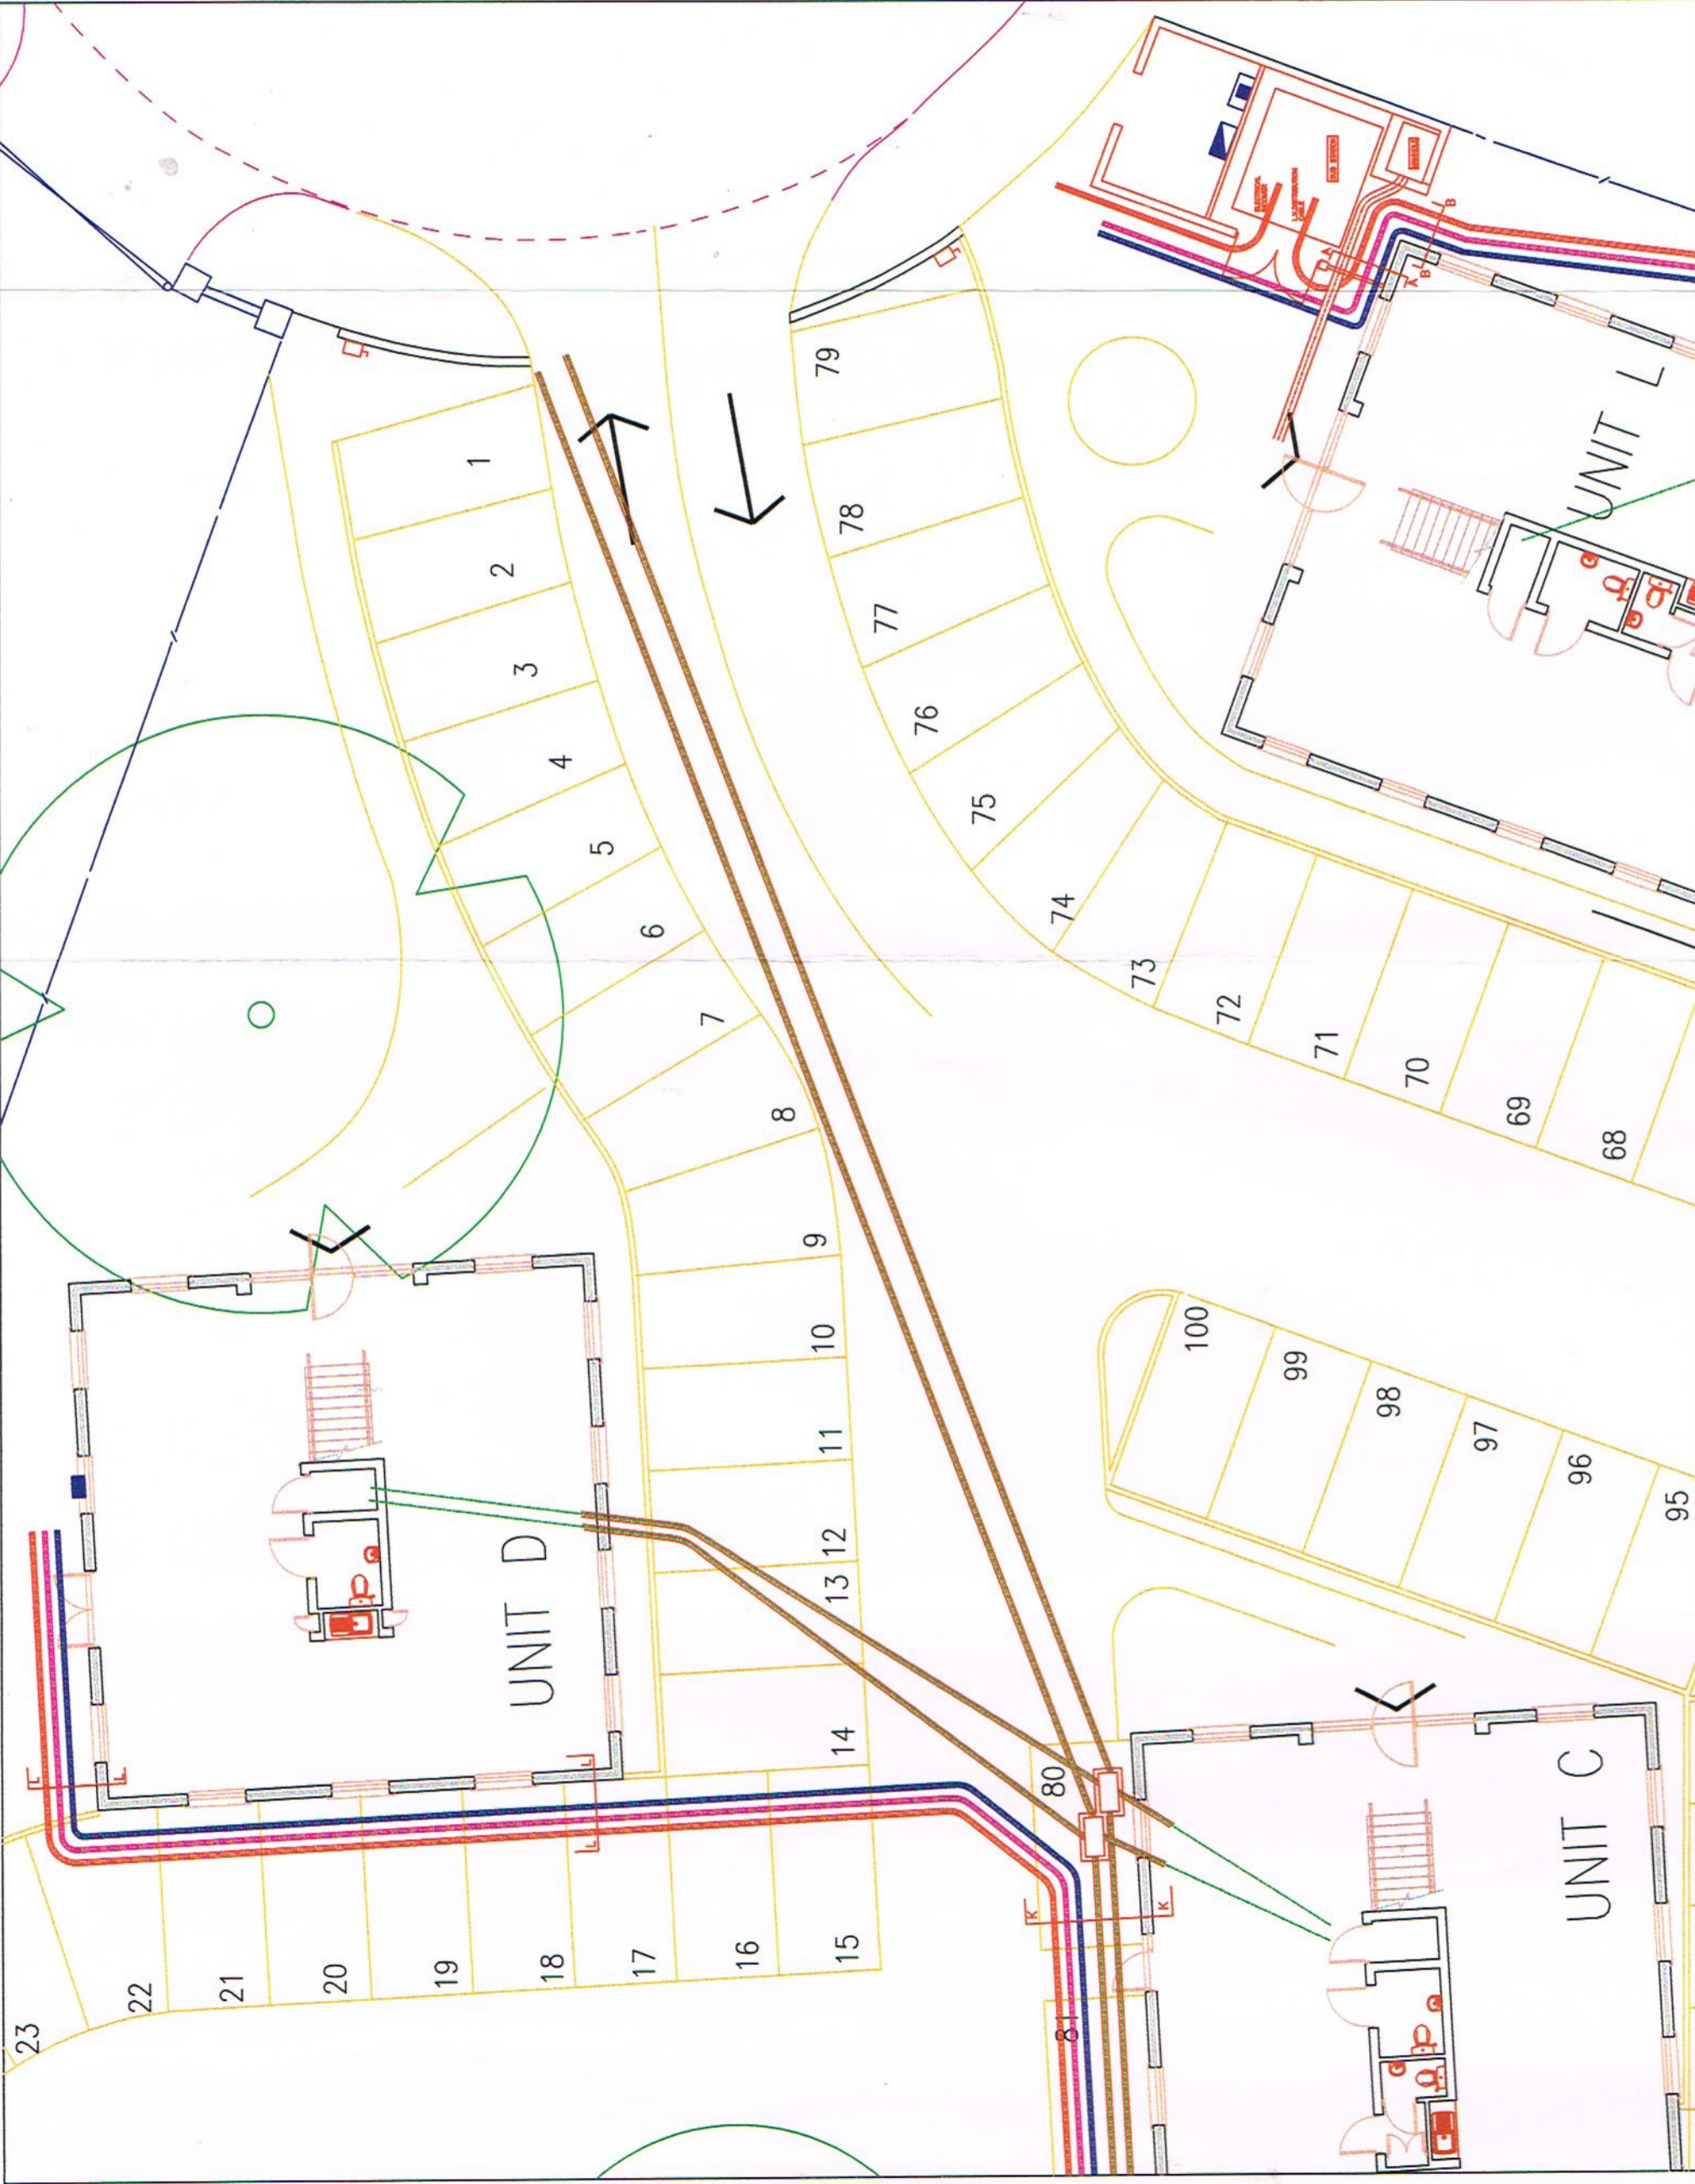

14.5.02