

Rev.	Date	Revisions
0	14.03.03	SMOKE DETECTORS ADDED IN MARK OFFICE AREA AS DUPLICATES OF UNITS SHOWN ON POWER & AUXILIARY DRAWINGS
1	14.03.07	REVISIONS AS PER REFERENCES CHANGED TO ACCORD WITH REVISED SCHEDULE OF WORKING DRAWING
2	14.12.07	ADJUSTING LIGHT RECOGNISED, DRAGIT AIRGIBES ADDED.
A	16.03.07	


BRUNEL
 ENGINEERING CONSULTANTS LTD
 1 Gloucester Row
 Clifton
 Bristol BS8 4AW
 TN 0117 973 0325 FX 0117 973 1857

Contract
REEDSPACE LIMITED
 PROPOSED OFFICE DEVELOPMENT
 EASTERN ROAD, BRACKNELL

Drawing Title
UNIT L - GROUND FLOOR LIGHTING SERVICES
 15.2.02

Drawing Status
TENDER/CONTRACT
 Date: DEC 2000 Scale: 1:50
 Drawing Number
9193/LGF/E2

Rev.
D

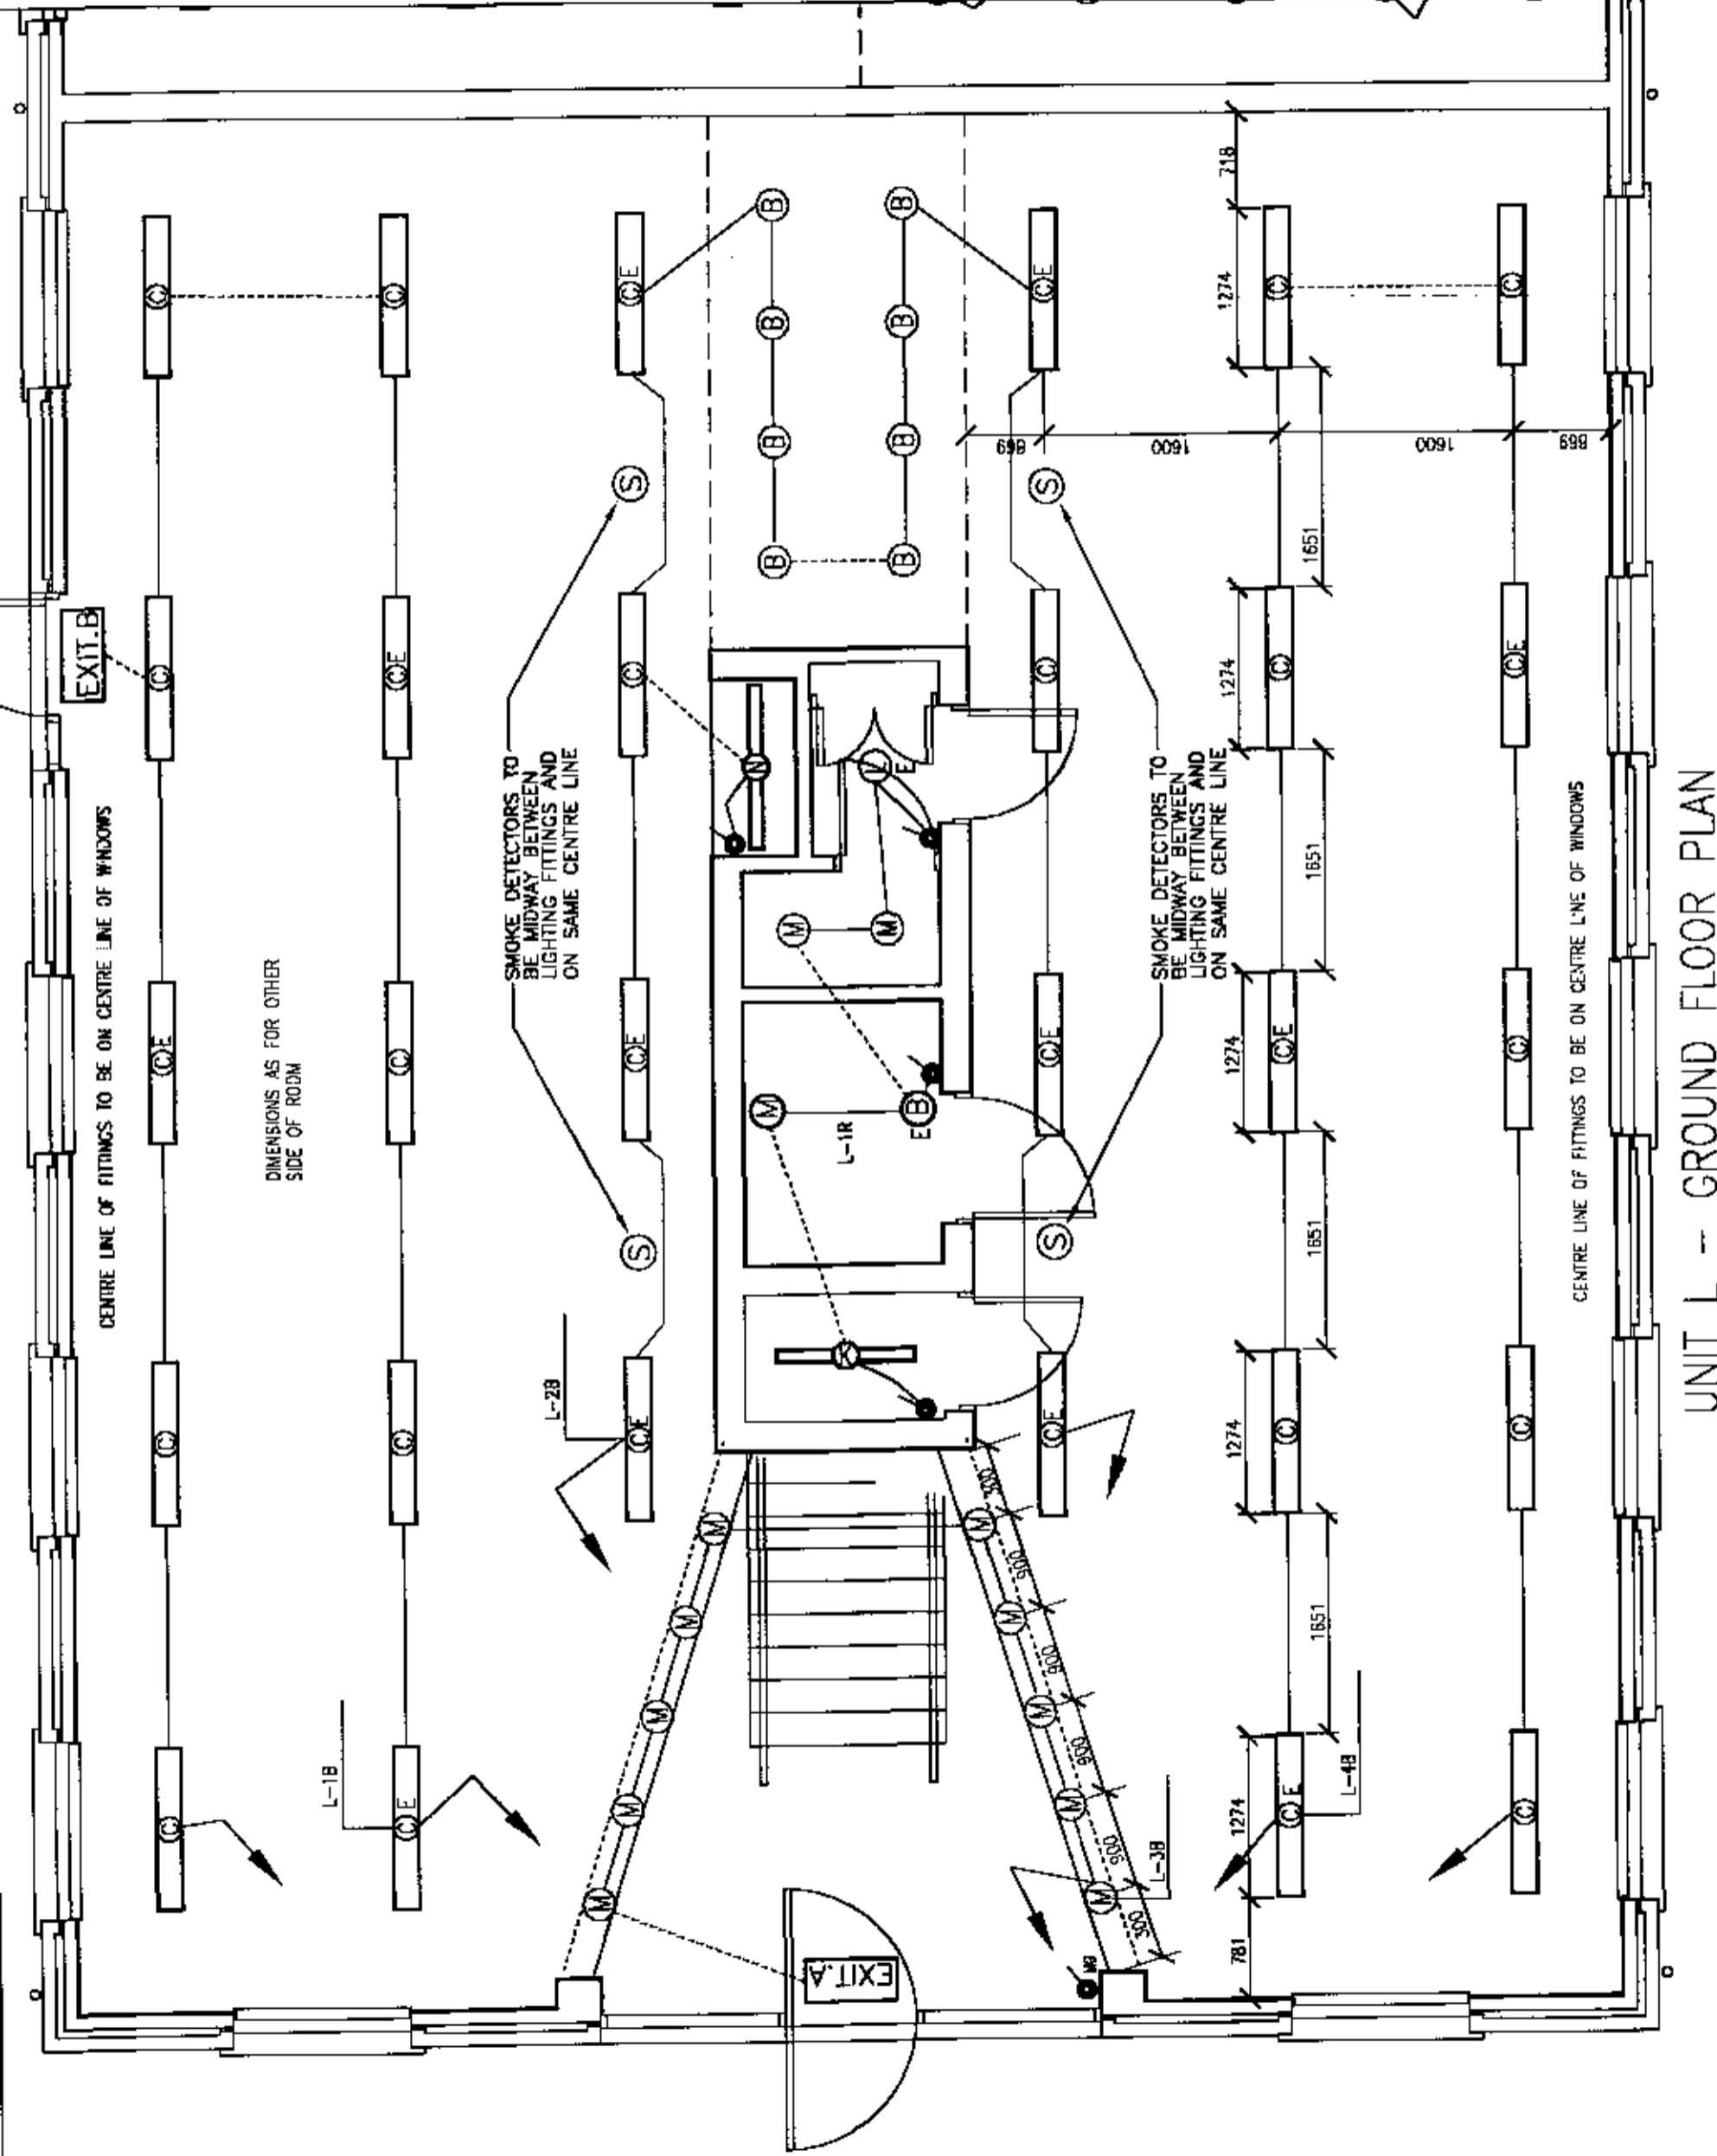

UNIT L - GROUND FLOOR PLAN