


Rev.	Date	Description
0	14/12/02	SMOKE DETECTORS ADDED TO MAIN OFFICE AREAS AS PER PLAN OF UNIT SUBMITTED ON POWER & APPURTENANCES
1	15/12/02	SMOKE DETECTORS ADDED TO MAIN OFFICE AREAS AS PER PLAN OF UNIT SUBMITTED ON POWER & APPURTENANCES
2	15/12/02	SMOKE DETECTORS ADDED TO MAIN OFFICE AREAS AS PER PLAN OF UNIT SUBMITTED ON POWER & APPURTENANCES
3	15/12/02	SMOKE DETECTORS ADDED TO MAIN OFFICE AREAS AS PER PLAN OF UNIT SUBMITTED ON POWER & APPURTENANCES
4	15/12/02	SMOKE DETECTORS ADDED TO MAIN OFFICE AREAS AS PER PLAN OF UNIT SUBMITTED ON POWER & APPURTENANCES
5	15/12/02	SMOKE DETECTORS ADDED TO MAIN OFFICE AREAS AS PER PLAN OF UNIT SUBMITTED ON POWER & APPURTENANCES
6	15/12/02	SMOKE DETECTORS ADDED TO MAIN OFFICE AREAS AS PER PLAN OF UNIT SUBMITTED ON POWER & APPURTENANCES
7	15/12/02	SMOKE DETECTORS ADDED TO MAIN OFFICE AREAS AS PER PLAN OF UNIT SUBMITTED ON POWER & APPURTENANCES
8	15/12/02	SMOKE DETECTORS ADDED TO MAIN OFFICE AREAS AS PER PLAN OF UNIT SUBMITTED ON POWER & APPURTENANCES
9	15/12/02	SMOKE DETECTORS ADDED TO MAIN OFFICE AREAS AS PER PLAN OF UNIT SUBMITTED ON POWER & APPURTENANCES
10	15/12/02	SMOKE DETECTORS ADDED TO MAIN OFFICE AREAS AS PER PLAN OF UNIT SUBMITTED ON POWER & APPURTENANCES

BRUNEL
 ENGINEERING CONSULTANTS LTD
 1 Gloucester Row
 Clifton
 Bristol BS8 4AW
 TEL 0117 973 0835 FAX 0117 973 1867

Contract
REEDSPACE LIMITED
 PROPOSED OFFICE DEVELOPMENT
 EASTERN ROAD, BRACKNELL

Drawing Title
UNIT C - GROUND FLOOR LIGHTING SERVICES
 15.2.02

Drawing Status
TENDER/CONTRACT
 Date: DEC 2002 Scale: 1:50
 Drawing Number
 9183/CG/FE2 Rev: D

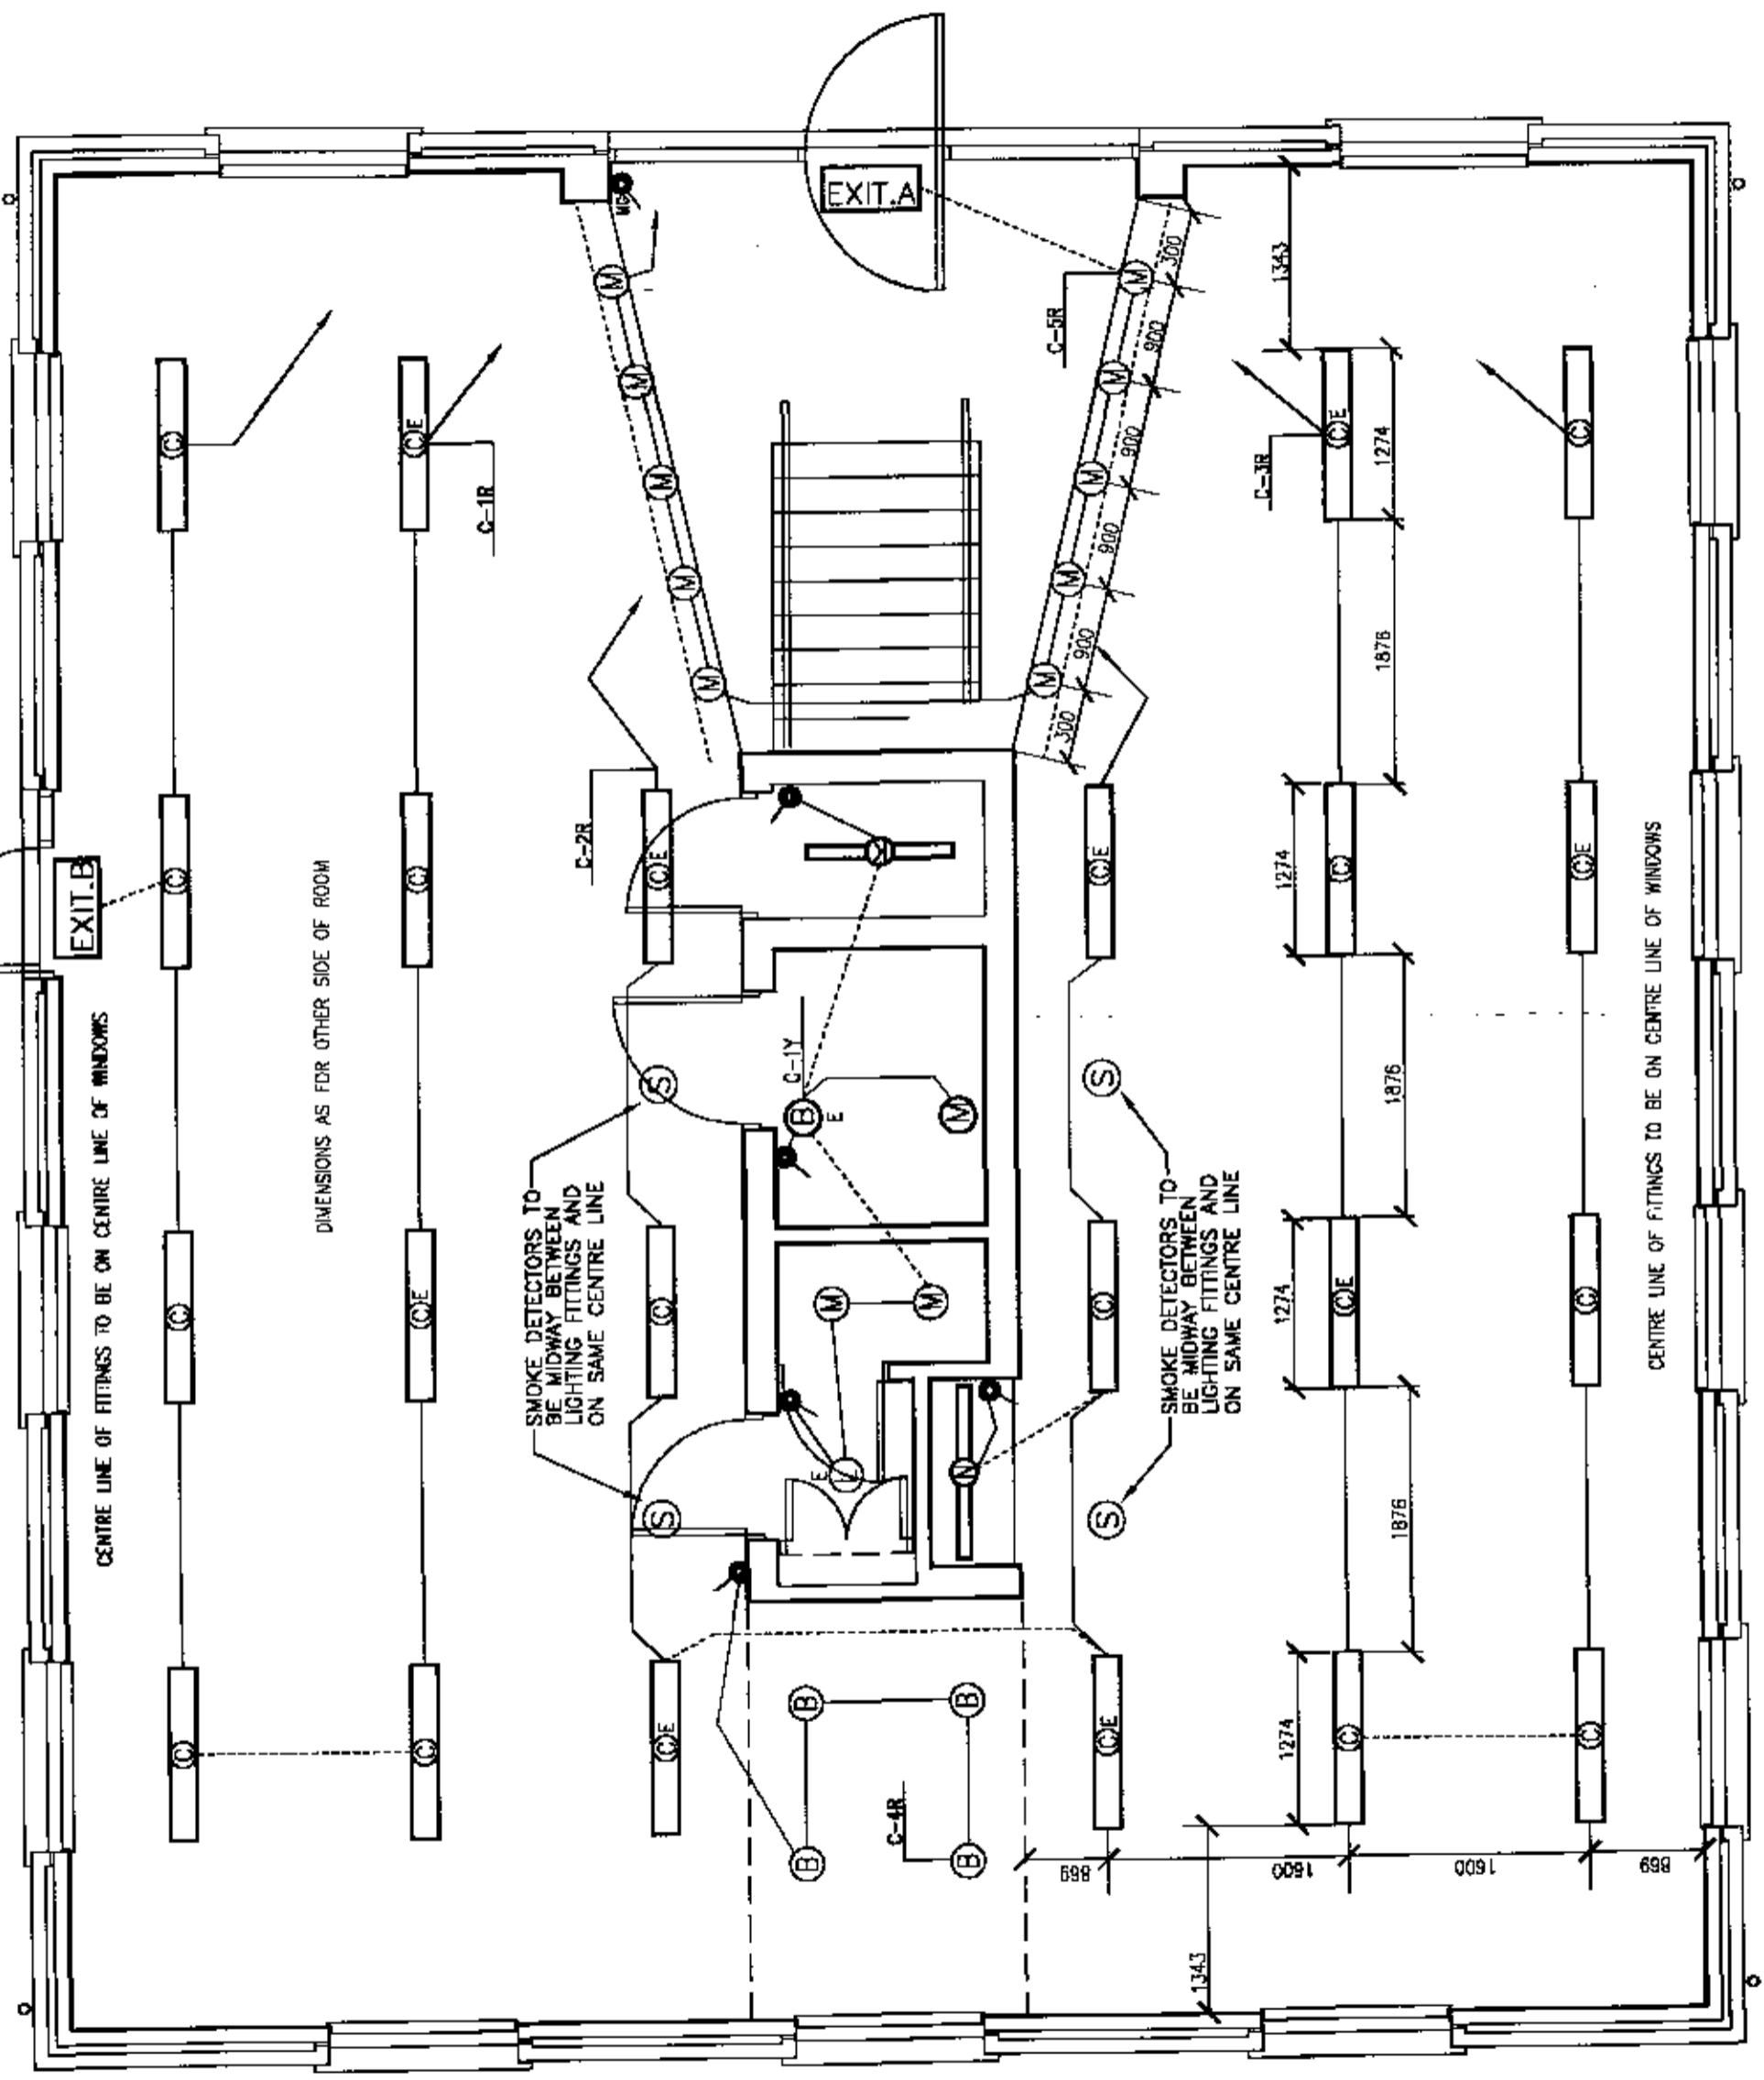

UNIT C - GROUND FLOOR PLAN