

Rev.	Date	Revisions
1	09.04.02	AS PER E-PILE QUOTES AND L. 106
2	10.04.02	REVISIONS MADE
3	10.04.02	REVISIONS MADE
4	10.04.02	REVISIONS MADE
5	10.04.02	REVISIONS MADE
6	10.04.02	REVISIONS MADE
7	10.04.02	REVISIONS MADE
8	10.04.02	REVISIONS MADE
9	10.04.02	REVISIONS MADE
10	10.04.02	REVISIONS MADE
11	10.04.02	REVISIONS MADE
12	10.04.02	REVISIONS MADE
13	10.04.02	REVISIONS MADE
14	10.04.02	REVISIONS MADE
15	10.04.02	REVISIONS MADE
16	10.04.02	REVISIONS MADE
17	10.04.02	REVISIONS MADE
18	10.04.02	REVISIONS MADE
19	10.04.02	REVISIONS MADE
20	10.04.02	REVISIONS MADE
21	10.04.02	REVISIONS MADE
22	10.04.02	REVISIONS MADE
23	10.04.02	REVISIONS MADE
24	10.04.02	REVISIONS MADE
25	10.04.02	REVISIONS MADE
26	10.04.02	REVISIONS MADE
27	10.04.02	REVISIONS MADE
28	10.04.02	REVISIONS MADE
29	10.04.02	REVISIONS MADE
30	10.04.02	REVISIONS MADE
31	10.04.02	REVISIONS MADE
32	10.04.02	REVISIONS MADE
33	10.04.02	REVISIONS MADE
34	10.04.02	REVISIONS MADE
35	10.04.02	REVISIONS MADE
36	10.04.02	REVISIONS MADE
37	10.04.02	REVISIONS MADE
38	10.04.02	REVISIONS MADE
39	10.04.02	REVISIONS MADE
40	10.04.02	REVISIONS MADE
41	10.04.02	REVISIONS MADE
42	10.04.02	REVISIONS MADE
43	10.04.02	REVISIONS MADE
44	10.04.02	REVISIONS MADE
45	10.04.02	REVISIONS MADE
46	10.04.02	REVISIONS MADE
47	10.04.02	REVISIONS MADE
48	10.04.02	REVISIONS MADE
49	10.04.02	REVISIONS MADE
50	10.04.02	REVISIONS MADE


BRUNEL
 ENGINEERING CONSULTANTS LTD
 1 Gloucester Row
 Clifton
 Bristol BS8 4AW
 TN. 0117 973 0635 FX. 0117 973 1887

Contract
REEDSPACE LIMITED
 PROPOSED OFFICE DEVELOPMENT
 EASTERN ROAD, BRACKNELL

Drawing Title
**UNIT J - FIRST FLOOR
 LIGHTING SERVICES**
 10.4.02

Drawing Status
TENDER/CONTRACT

Date : DEC 2000 Scale : 1 : 50
 Drawing Number
9193AJFFE2
 Rev. **D**

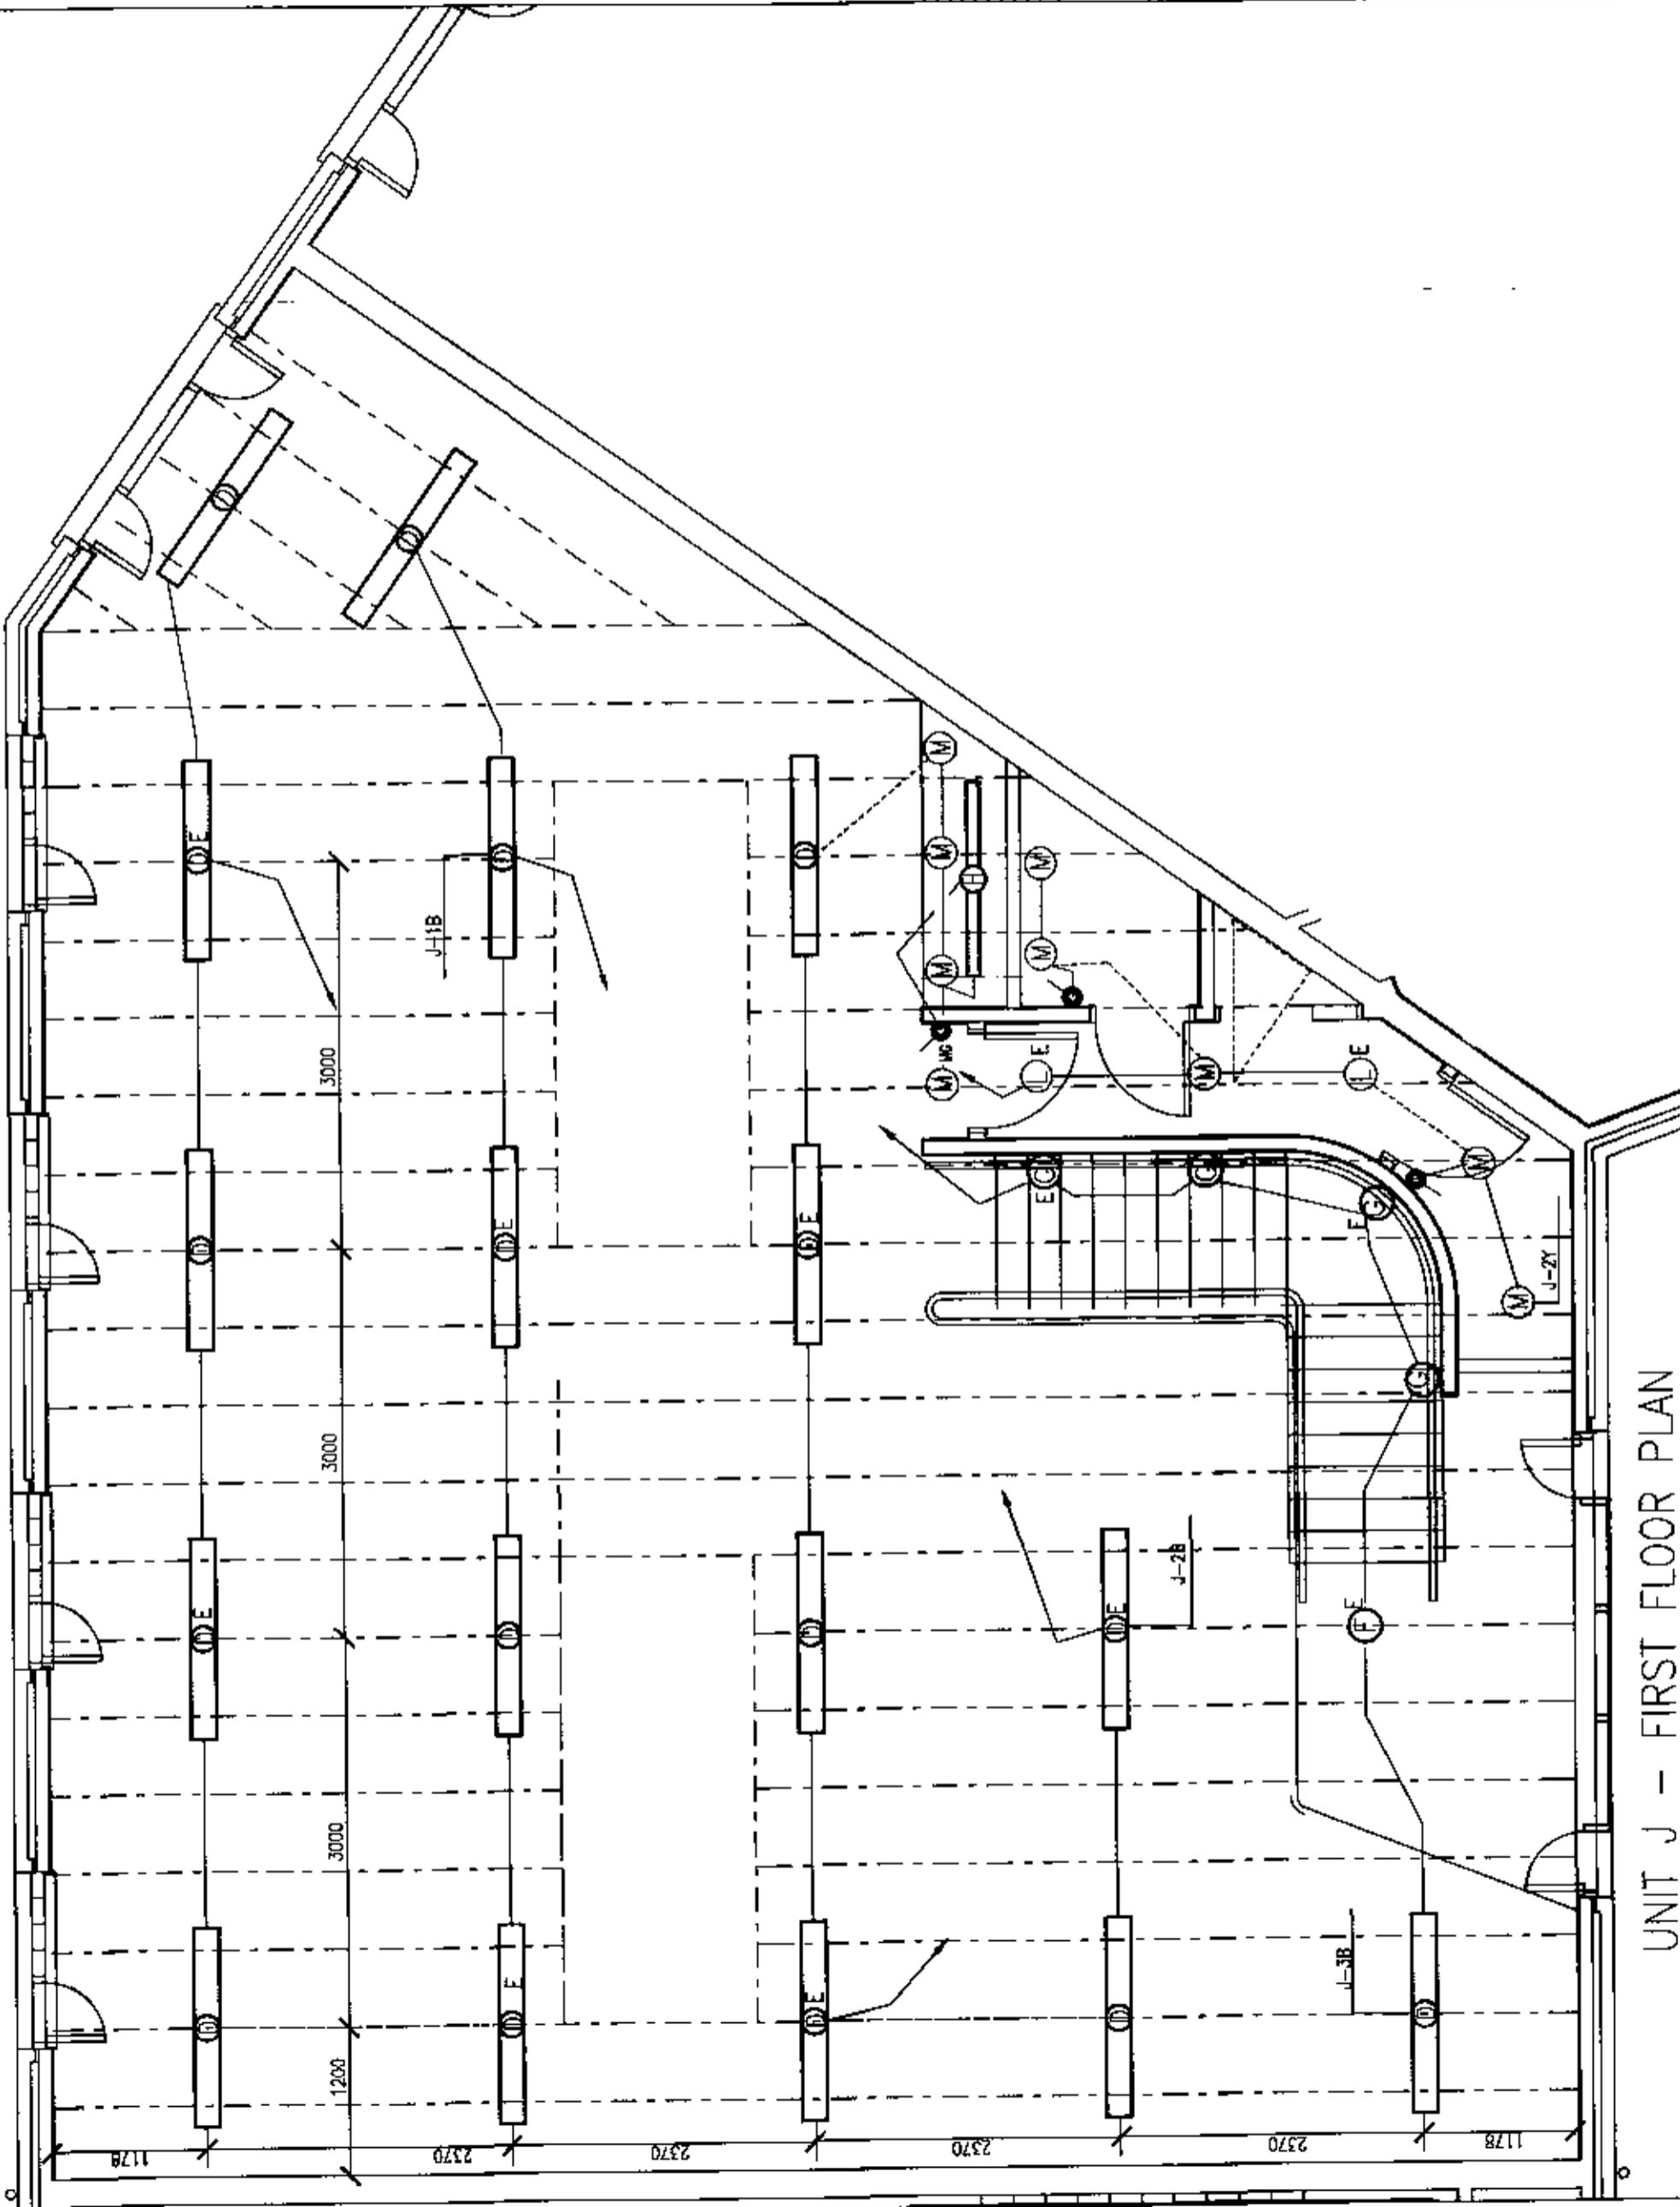

UNIT J - FIRST FLOOR PLAN