


UNIT A - FIRST FLOOR PLAN

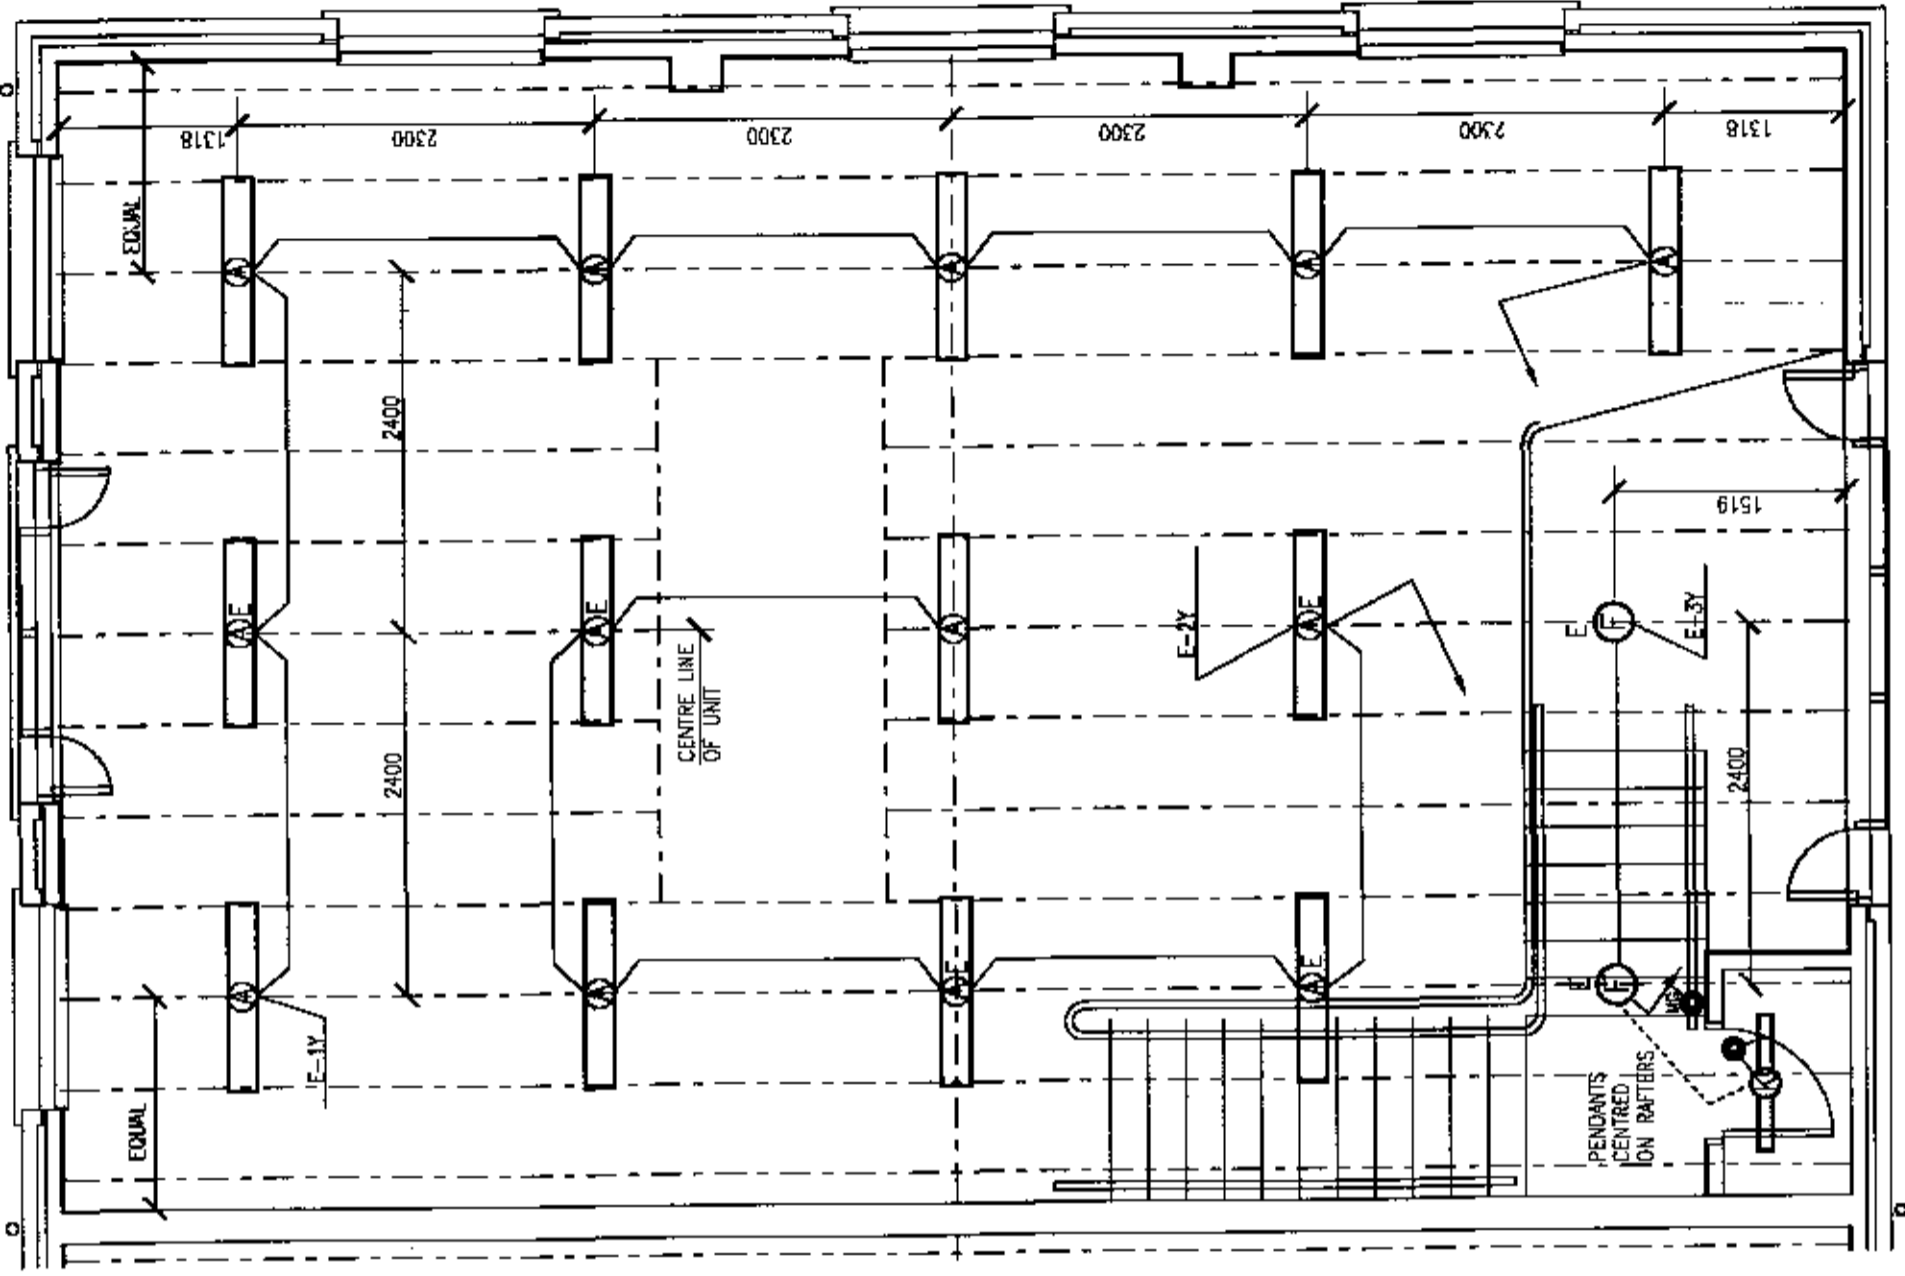

UNIT E - FIRST FLOOR PLAN

BRUNEL ENGINEERING CONSULTANTS LTD 1 Gloucester Row Clifton Bristol BS8 4AW TN. 0117 973 0835 FX. 0117 973 1867	Contract REEDSPACE LIMITED PROPOSED OFFICE DEVELOPMENT EASTERN ROAD, BRACKNELL	Drawing Title UNITS A & E - FIRST FLOOR LIGHTING SERVICES 25.1.02	Drawing Status TENDER/CONTRACT
Date 19.12.81	Revision 1 REVISIONS ADDED TO TYPE F FIXTURES 2 CLIPPING FIXTURES TYPE P CHANGED TO TYPE L	Scale 1 : 50	Drawing Number 9193A-E/FF/E2
			Rev. B